


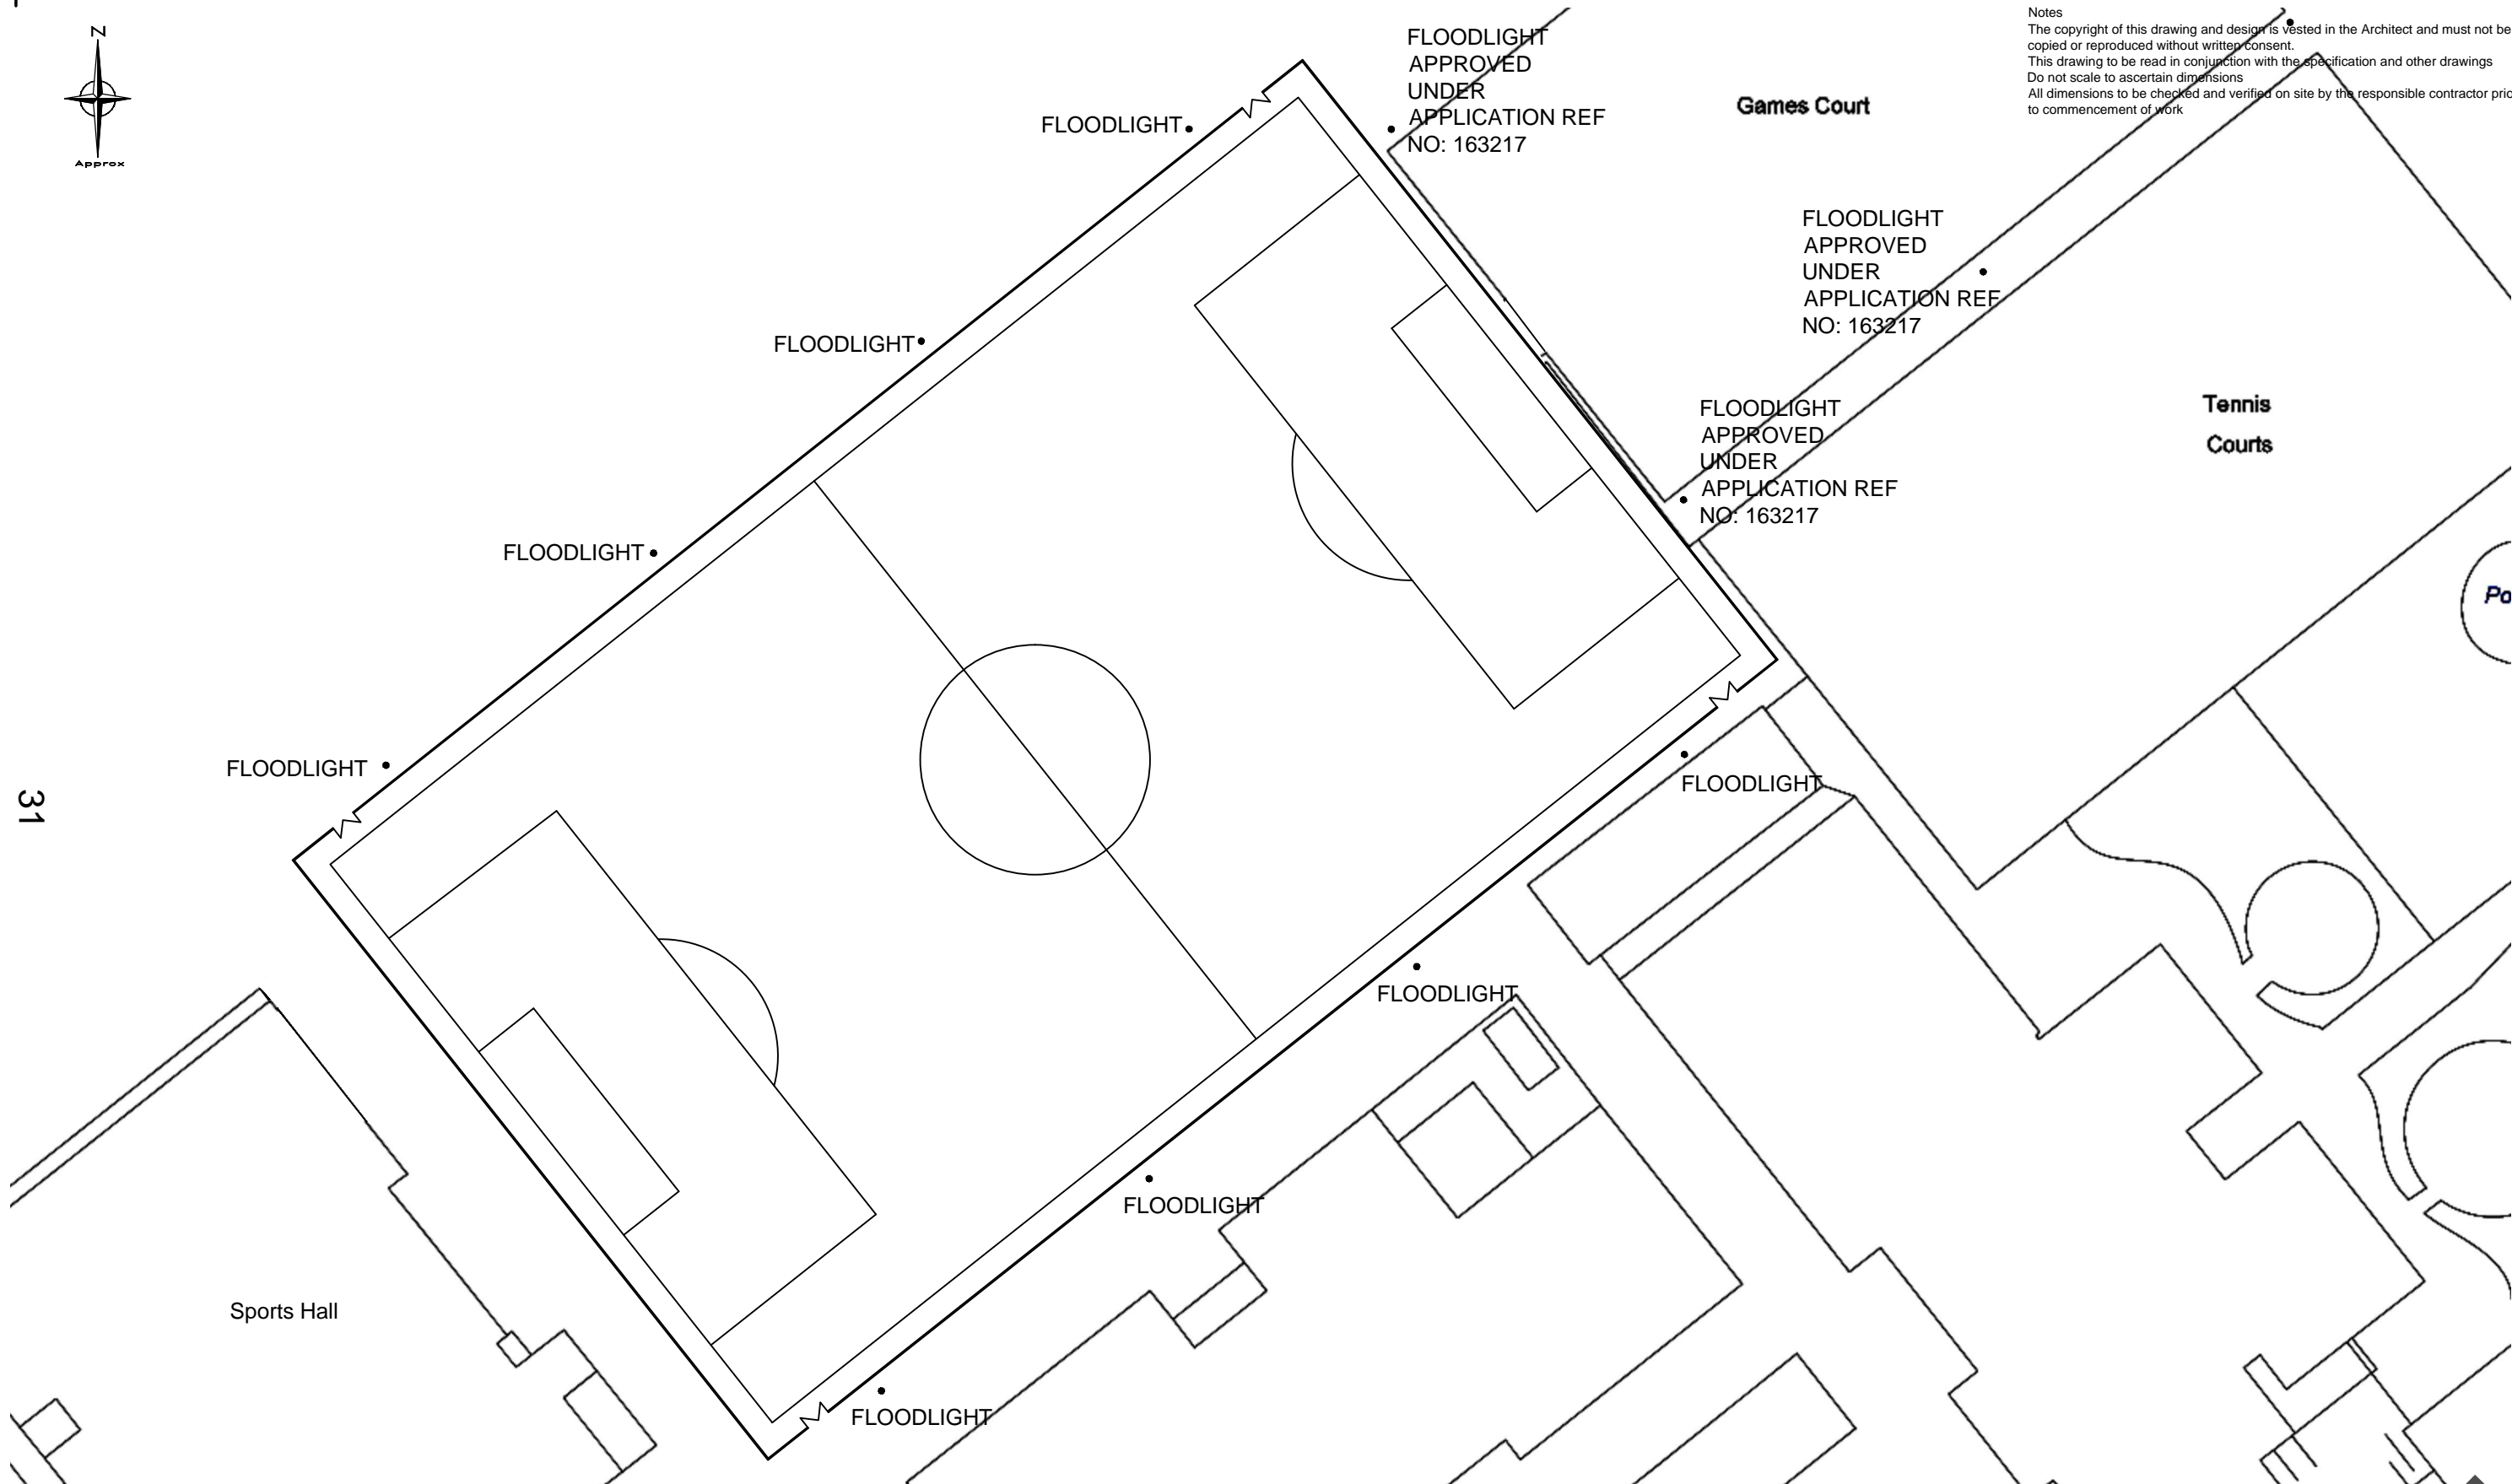

Notes
The copyright of this drawing and design is vested in the Architect and must not be copied or reproduced without written consent.
This drawing to be read in conjunction with the specification and other drawings
Do not scale to ascertain dimensions
All dimensions to be checked and verified on site by the responsible contractor prior to commencement of work



A.	PROPOSED FLOODLIGHT POSITIONS AMENDED.	MS	08.12.17
Rev	Details	Alt.	Date/Chk

CLIENT
Waingels College.

PROJECT
New 4G Pitch Development at Waingels College, Waingels Rd, Reading, RG5 4RF

DRAWING
Proposed Site Plan.

DRAWING NUMBER	REVISION	SCALE	DATE
Rea-051-026	A	1:500	DEC'17
		@A3	
DRAWN BY	CHECKED BY		
MS	-		

Sigma Σ
Home Solutions

The Work Space
All Saints Rd, All Saints
Wolverhampton WV2 1EL
Tel: 07749 525955
SHS@sigma-surveying.co.uk
www.sigma-surveying.co.uk

This page is intentionally left blank